

UMAB
MEDICAL
RESEARCH
BUILDING

108 N. Greene St.
Baltimore,
Maryland


PENTHOUSE/ROOF
and PENTHOUSE
ROOF PLAN

Project Number	06991-001-030
Date	1 OCT 91
Project Manager	J. WOODLEY
Project Designer	J. LAVIGNE
Project Architect	T. GUARINO
Structural	S. PUNCH
Mechanical	S. MEHRAD R. LETOBTTER
Electrical	D. ANOIA
Drawn By	D. FINCHER
Scale	1/8" = 1'-0"
Revisions	

UMAB Approval

UMAB Project Code
69-173.02
Sheet Number

A1-06

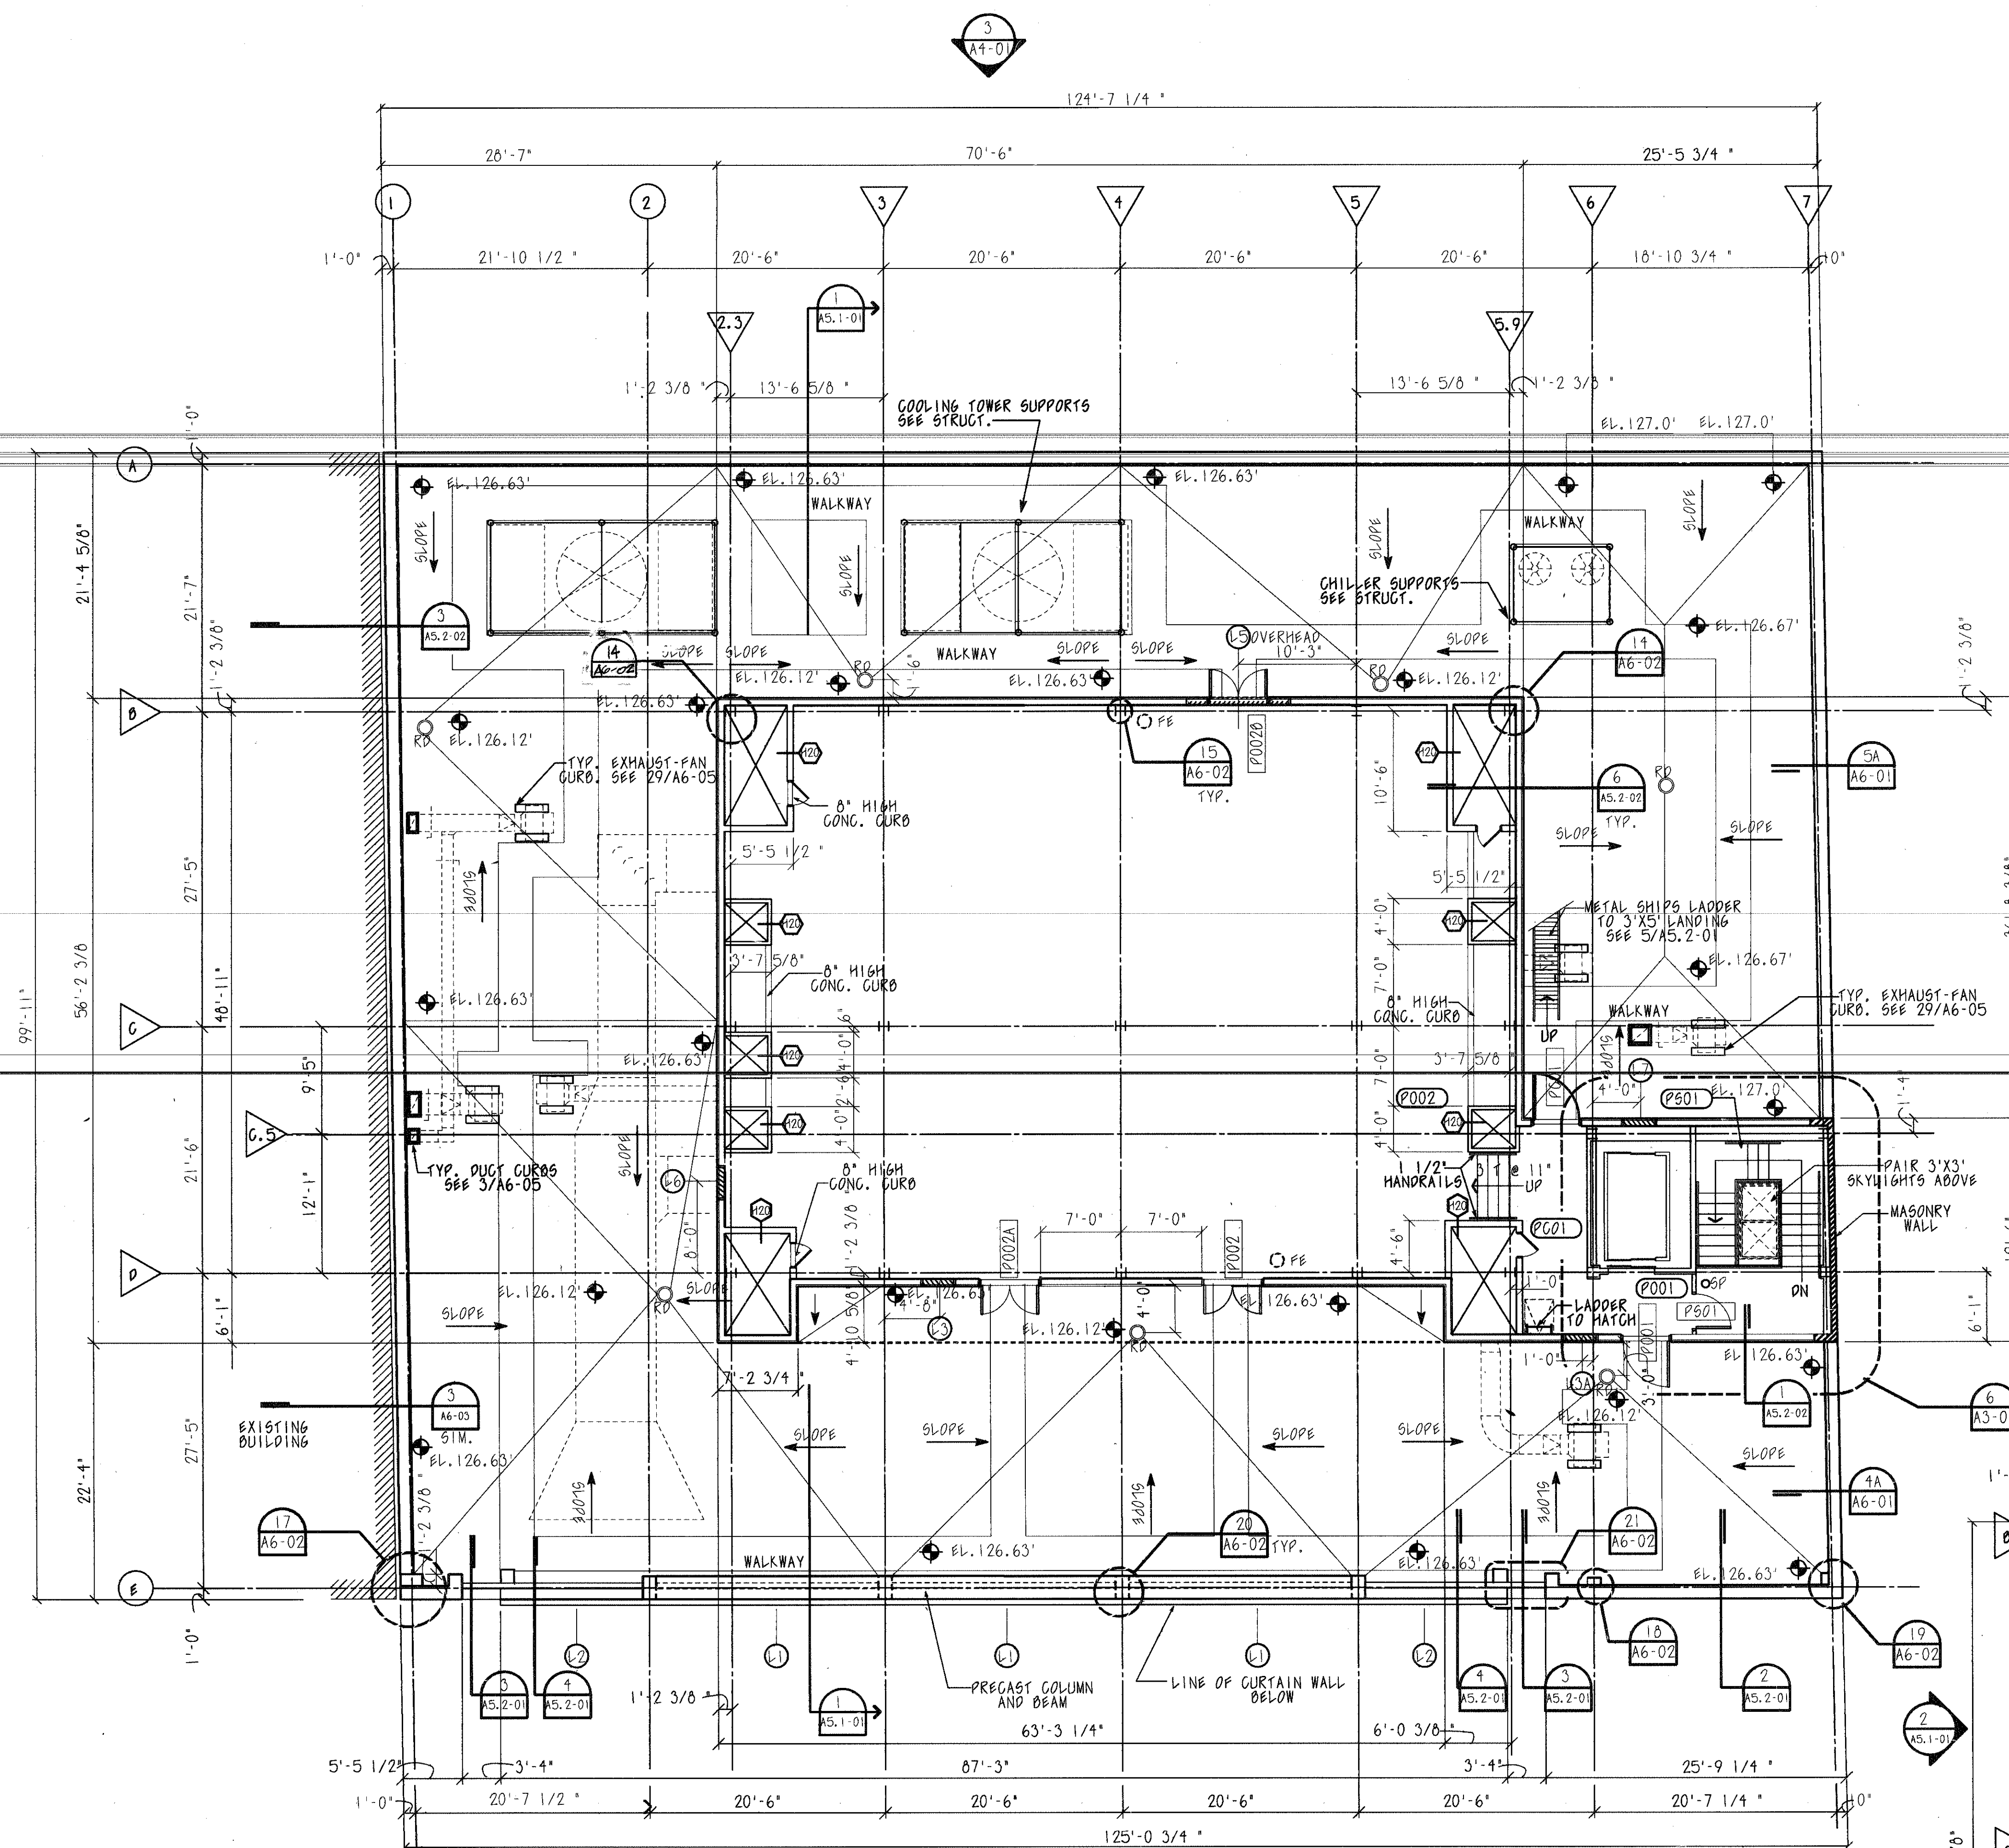


ROOF/PENTHOUSE/FLOOR PLAN

SCALE: 1/8" = 1'-0"

PENTHOUSE SQUARE FOOTAGE

GROSS AREA 4205.5 SF

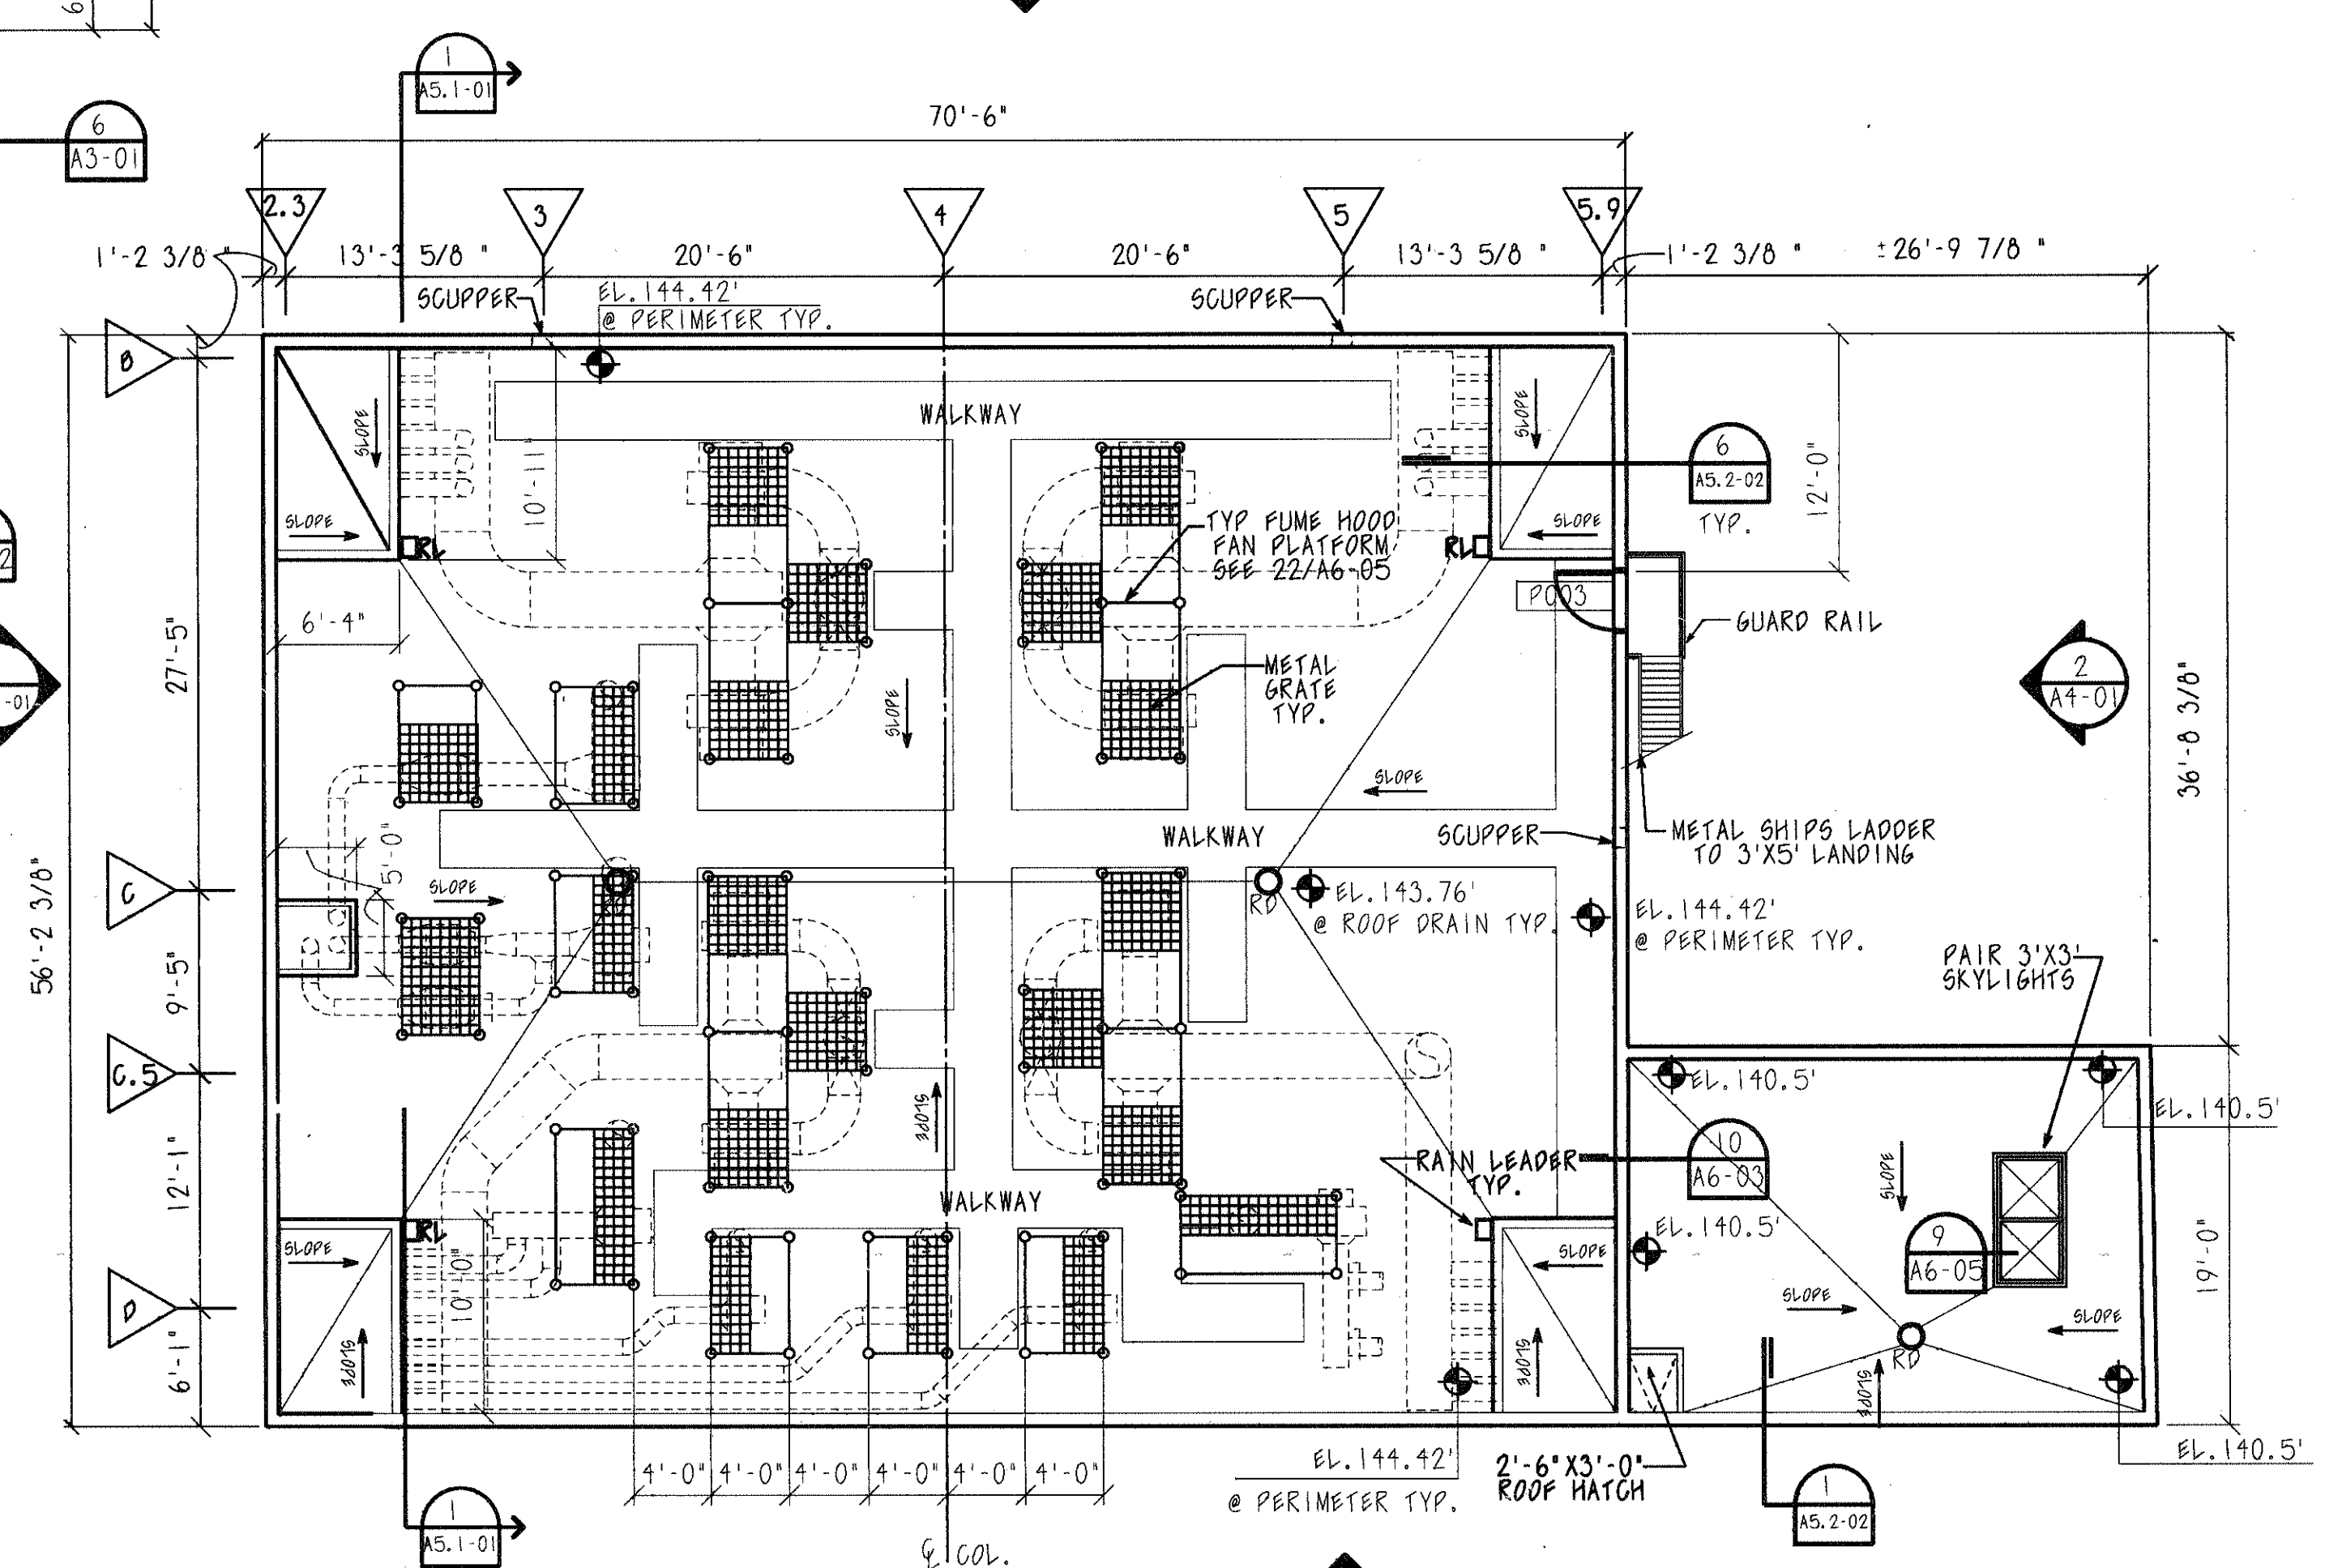

PENTHOUSE ROOF PLAN

